


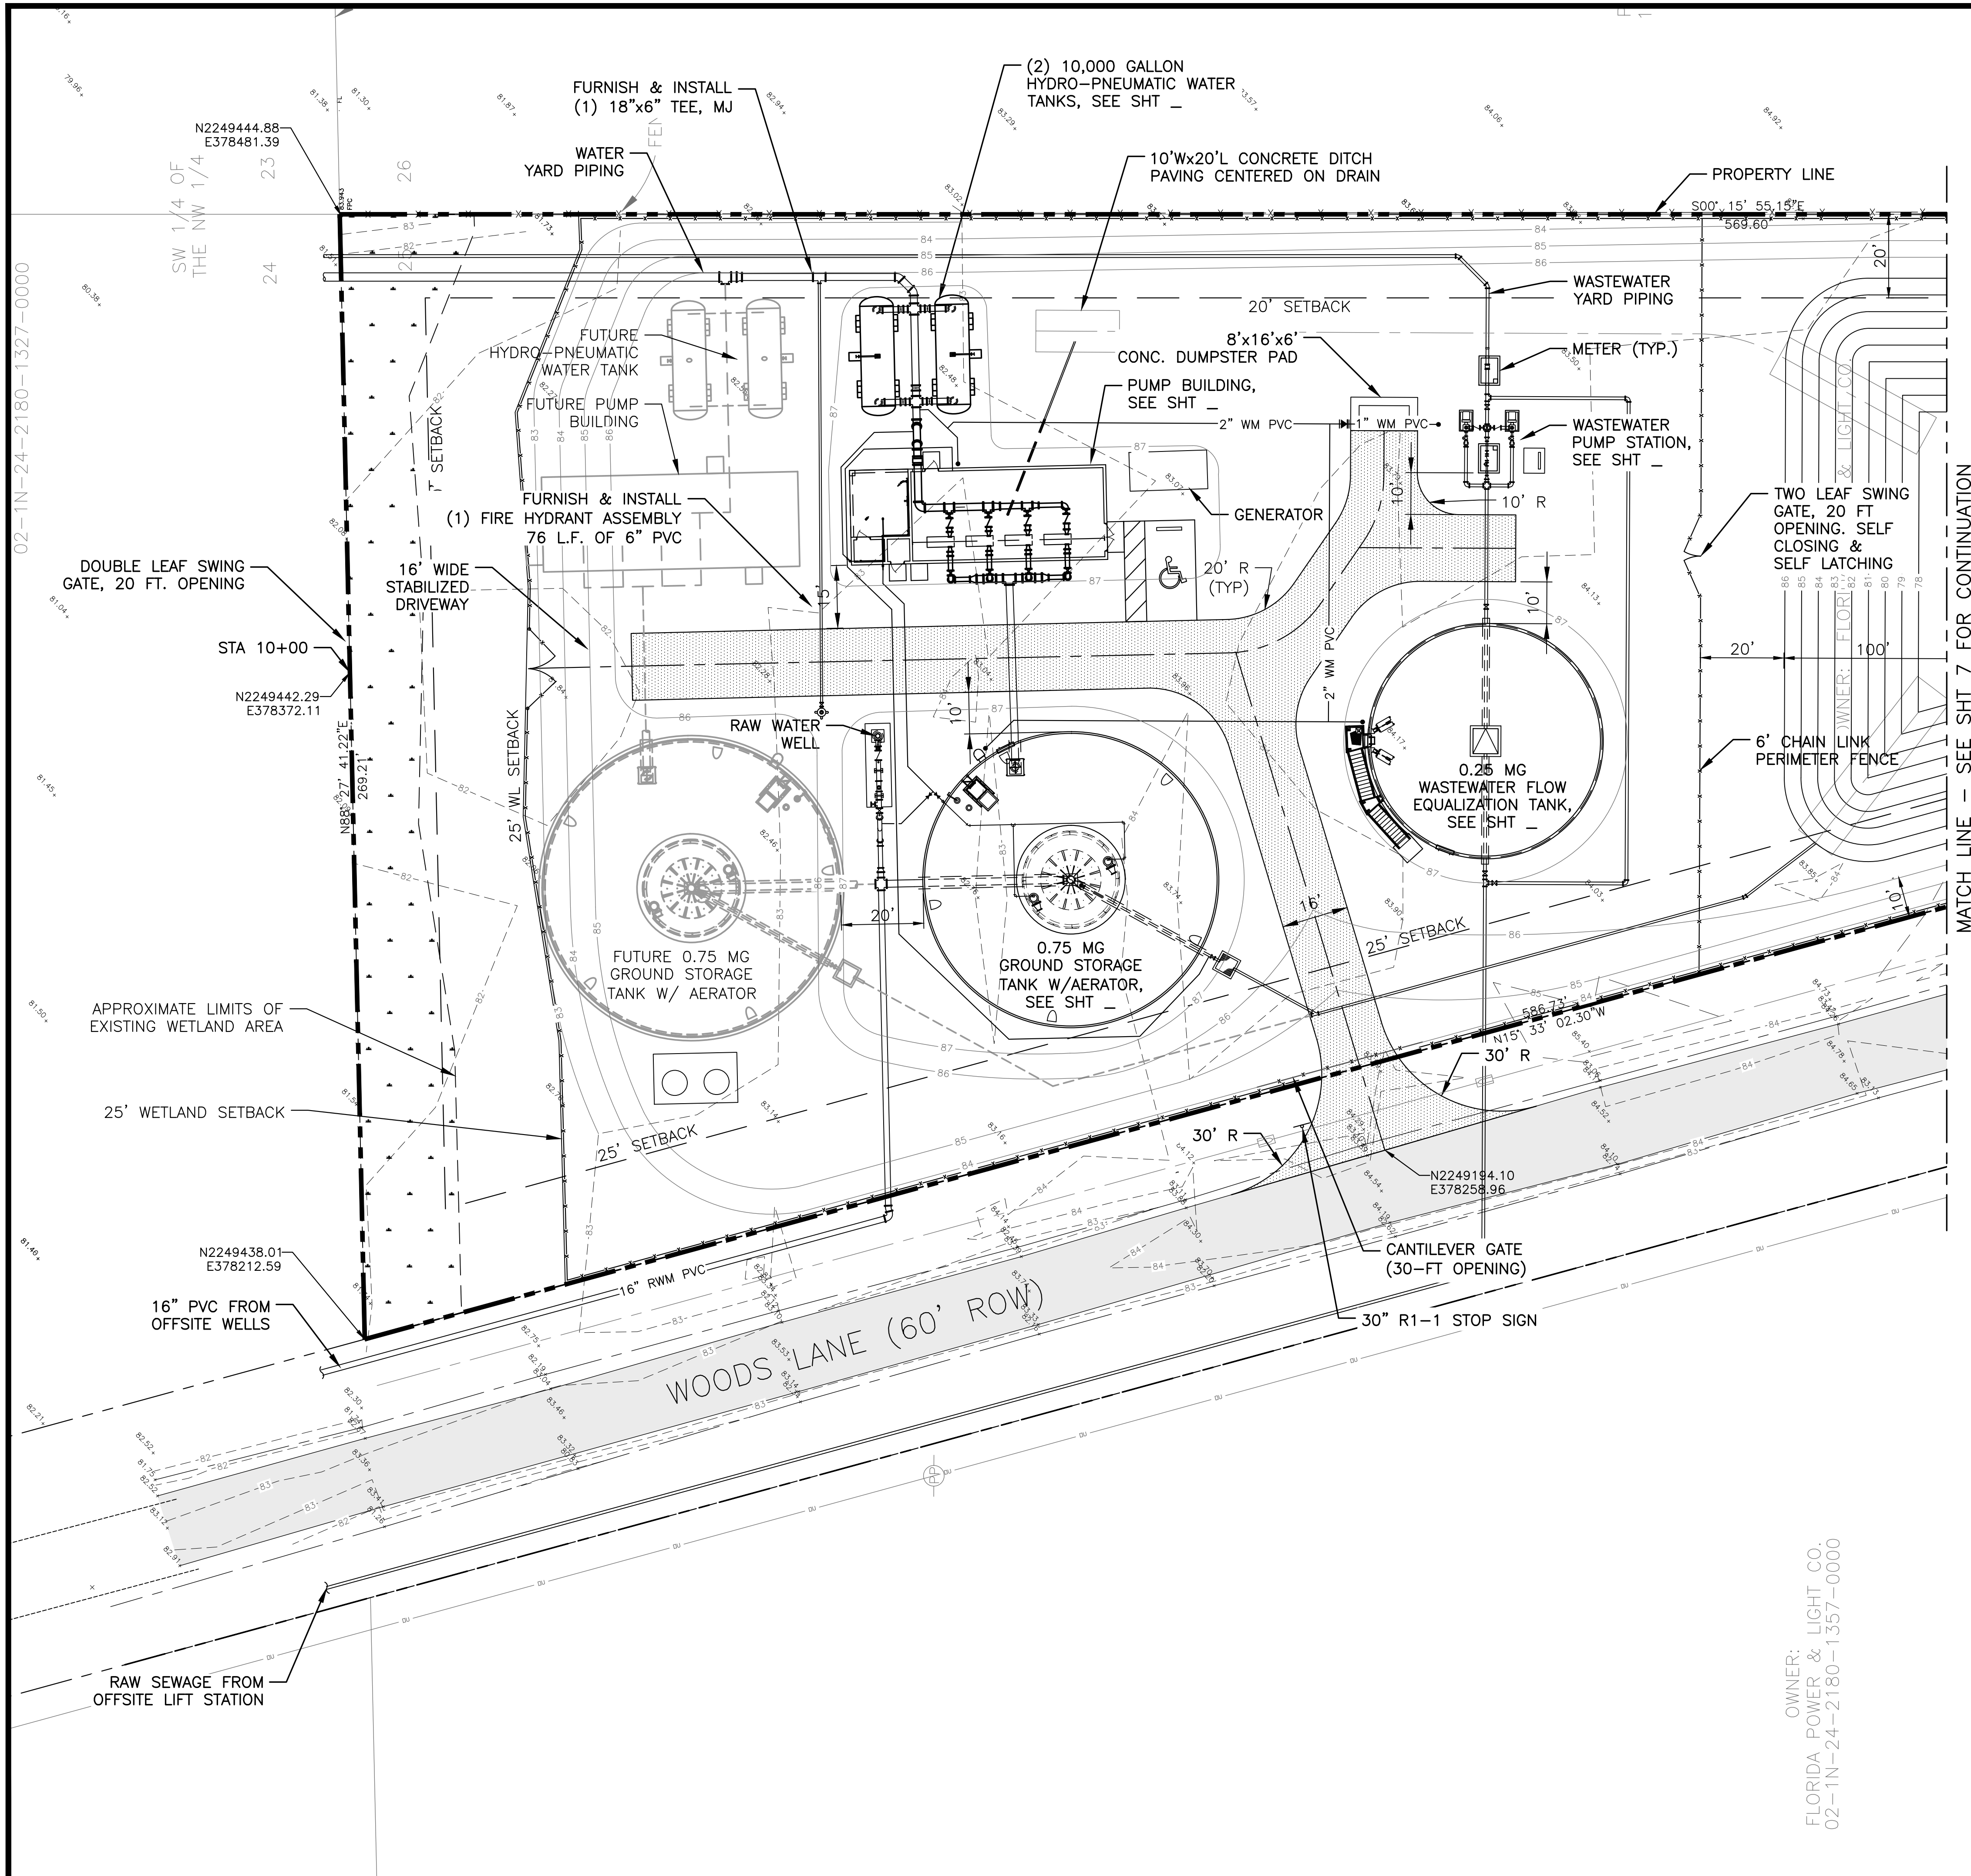

N
SCALE: 1" = 20'

OWNER:
FLORIDA POWER & LIGHT CO.
02-1N-24-2180-1327-0000

MATCH LINE - SEE SHT 7 FOR CONTINUATION

TOWN OF CALLAHAN Crawford Diamond Development Water & Sewer Facilities Site Plan Nassau County, Florida		JOB NO. 0302-27-1 SHEET NO. 6	
MITTAUER & ASSOCIATES, INC. CONSULTING ENGINEERS 580-1 WELLS ROAD, ORANGE PARK, FLORIDA 32073 TEL. (904) 278-0030 FAX. (904) 278-0840		DESIGNER: TPN DRAWN: MAL PROJ. MGR: TPN DATE: 03/24/21 1 INCH = 20 FEET	
REVISION DESCRIPTION		NO.	DATE
		BY	