
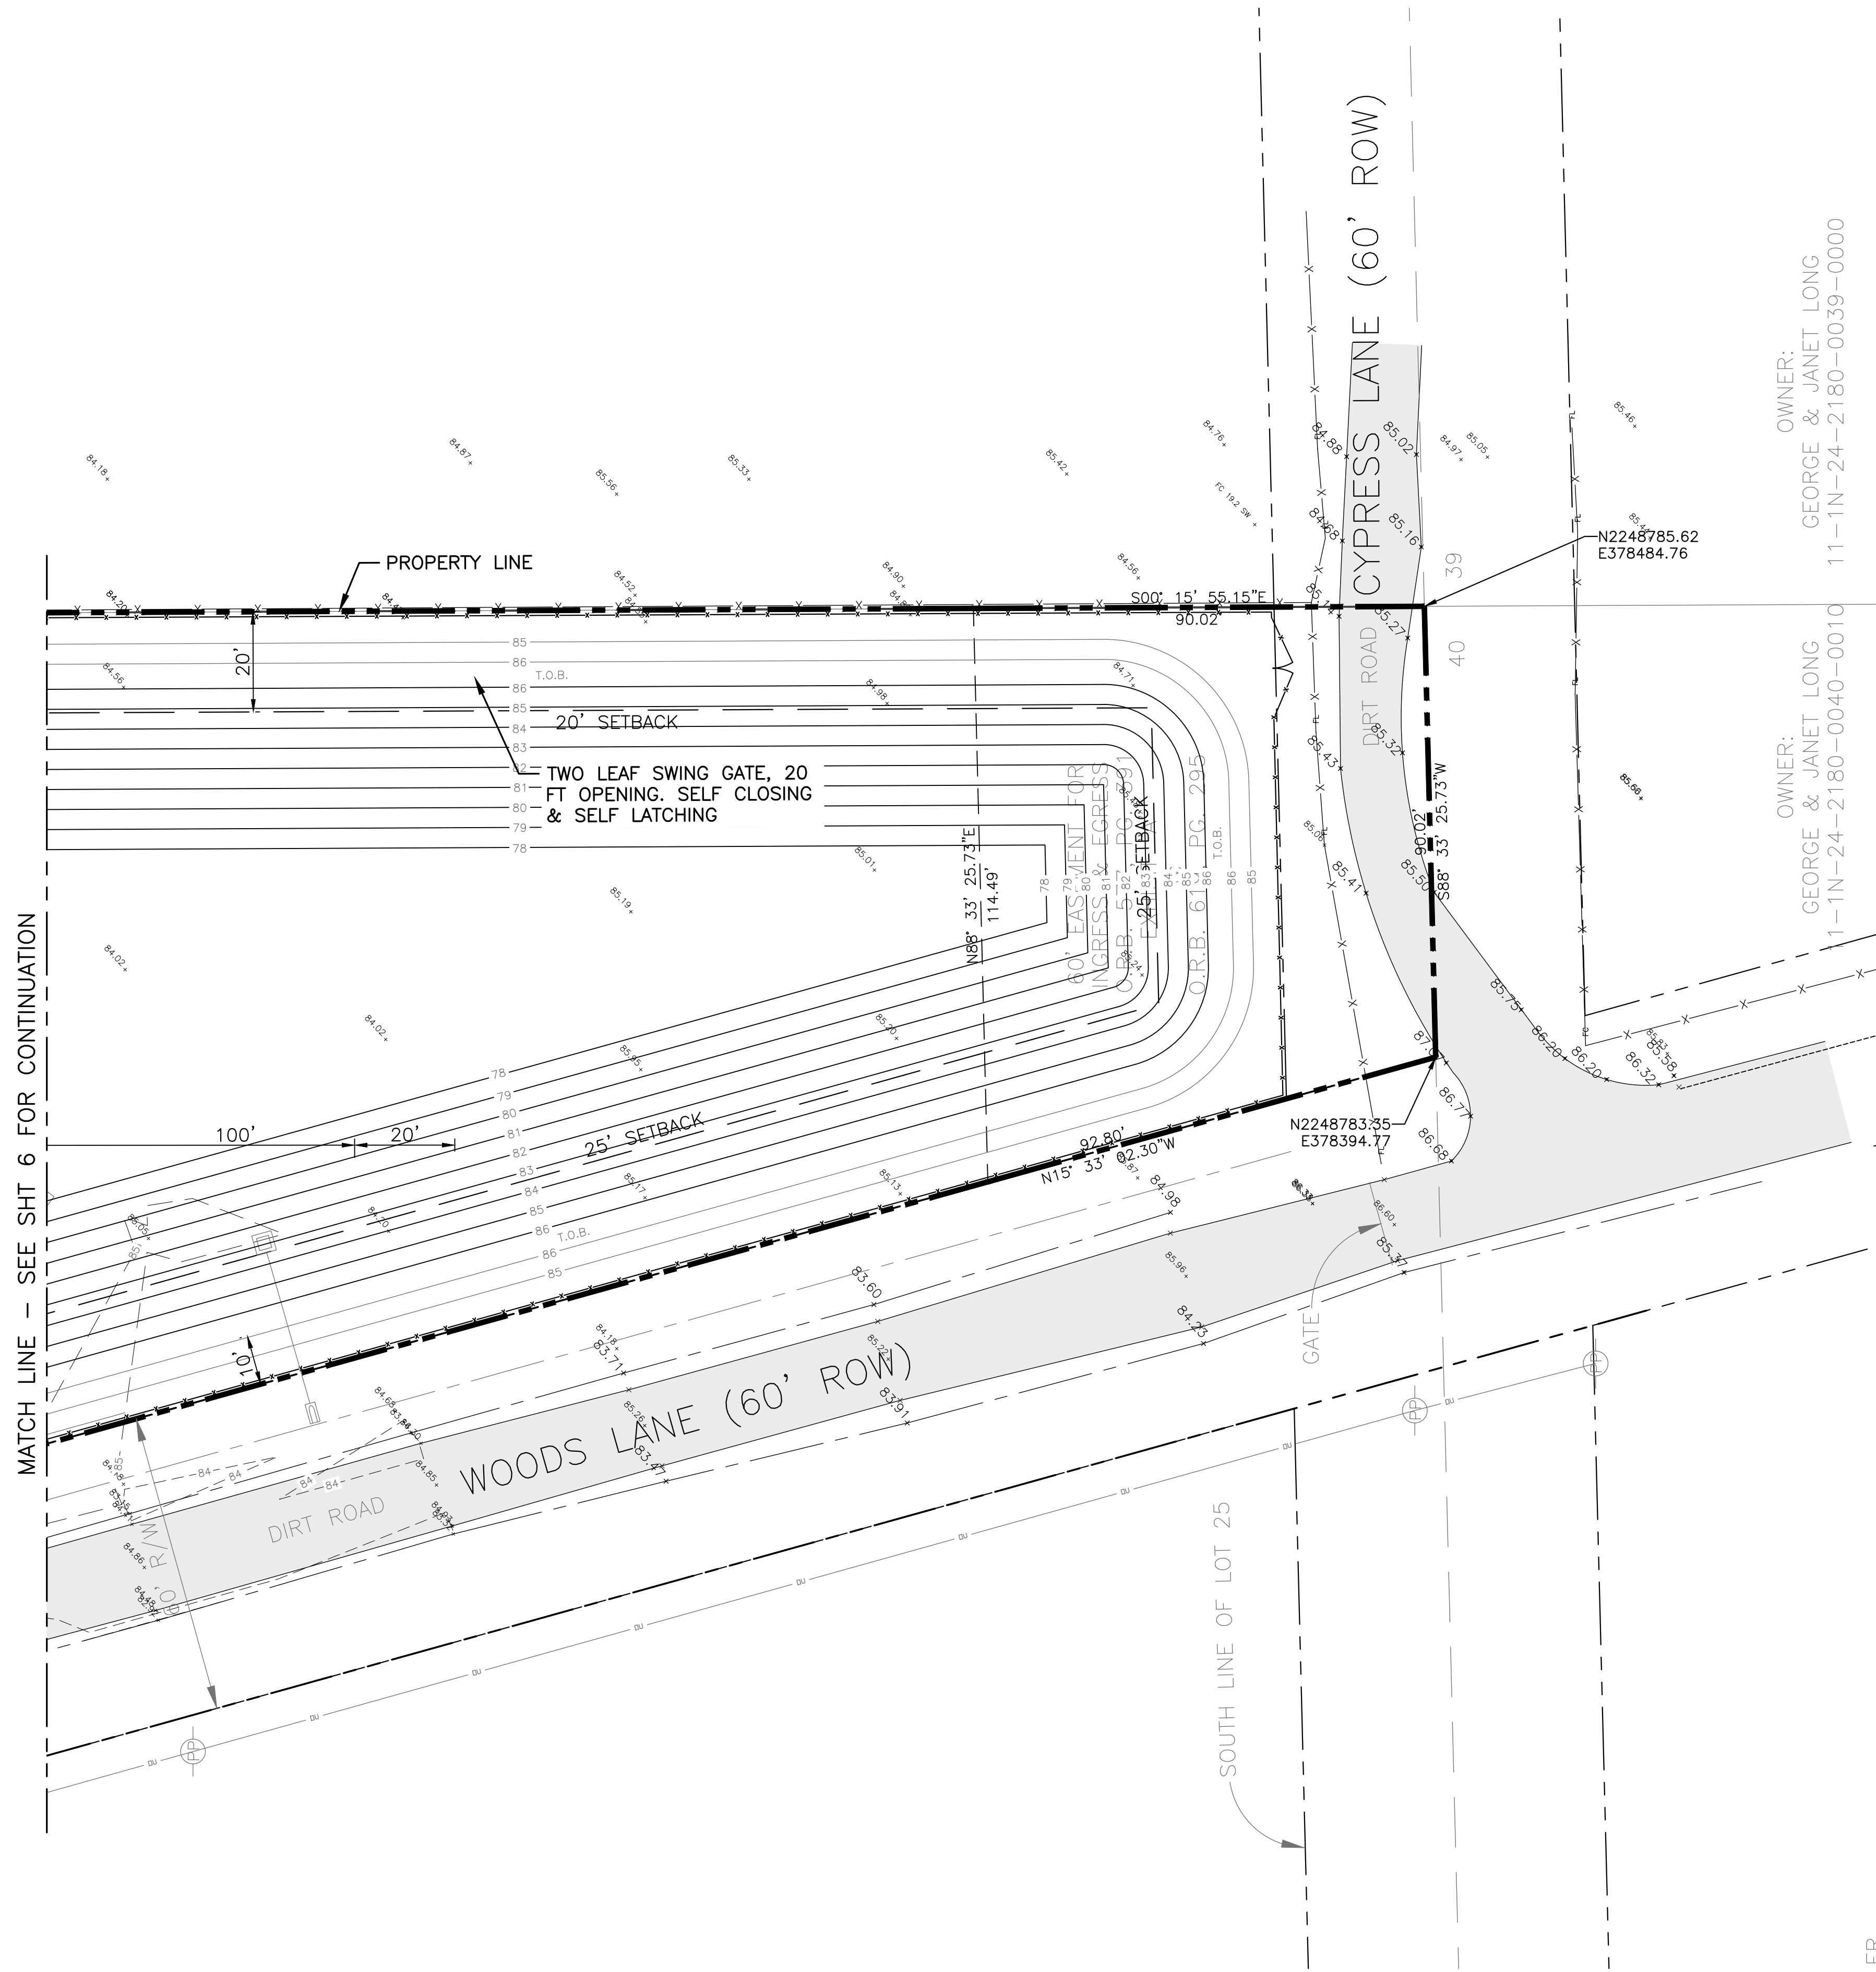


M:\CAD Files\Callahan\0302271 Crawford Diamond Development\Design\SH15-6 Siteplan.dwg, 4/26/2021 4:20:47 PM

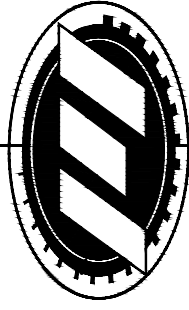

N
SCALE: 1" = 20'

TOWN OF CALLAHAN Crawford Diamond Development Water & Sewer Facilities Site Plan Nassau County, Florida		JOB NO. 0302-27-1 SHEET NO. 7		DESIGNER TPN DRAWN MAL PROJECT TPN DATE 03/24/21 1 INCH		NO DATE BY REVISION DESCRIPTION			
 MITTAUER & ASSOCIATES, INC. CONSULTING ENGINEERS 580-1 WELLS ROAD, ORANGE PARK, FLORIDA 32073 TEL. (904) 278-0030 FAX. (904) 278-0840 FLORIDA CA NO. 6569									