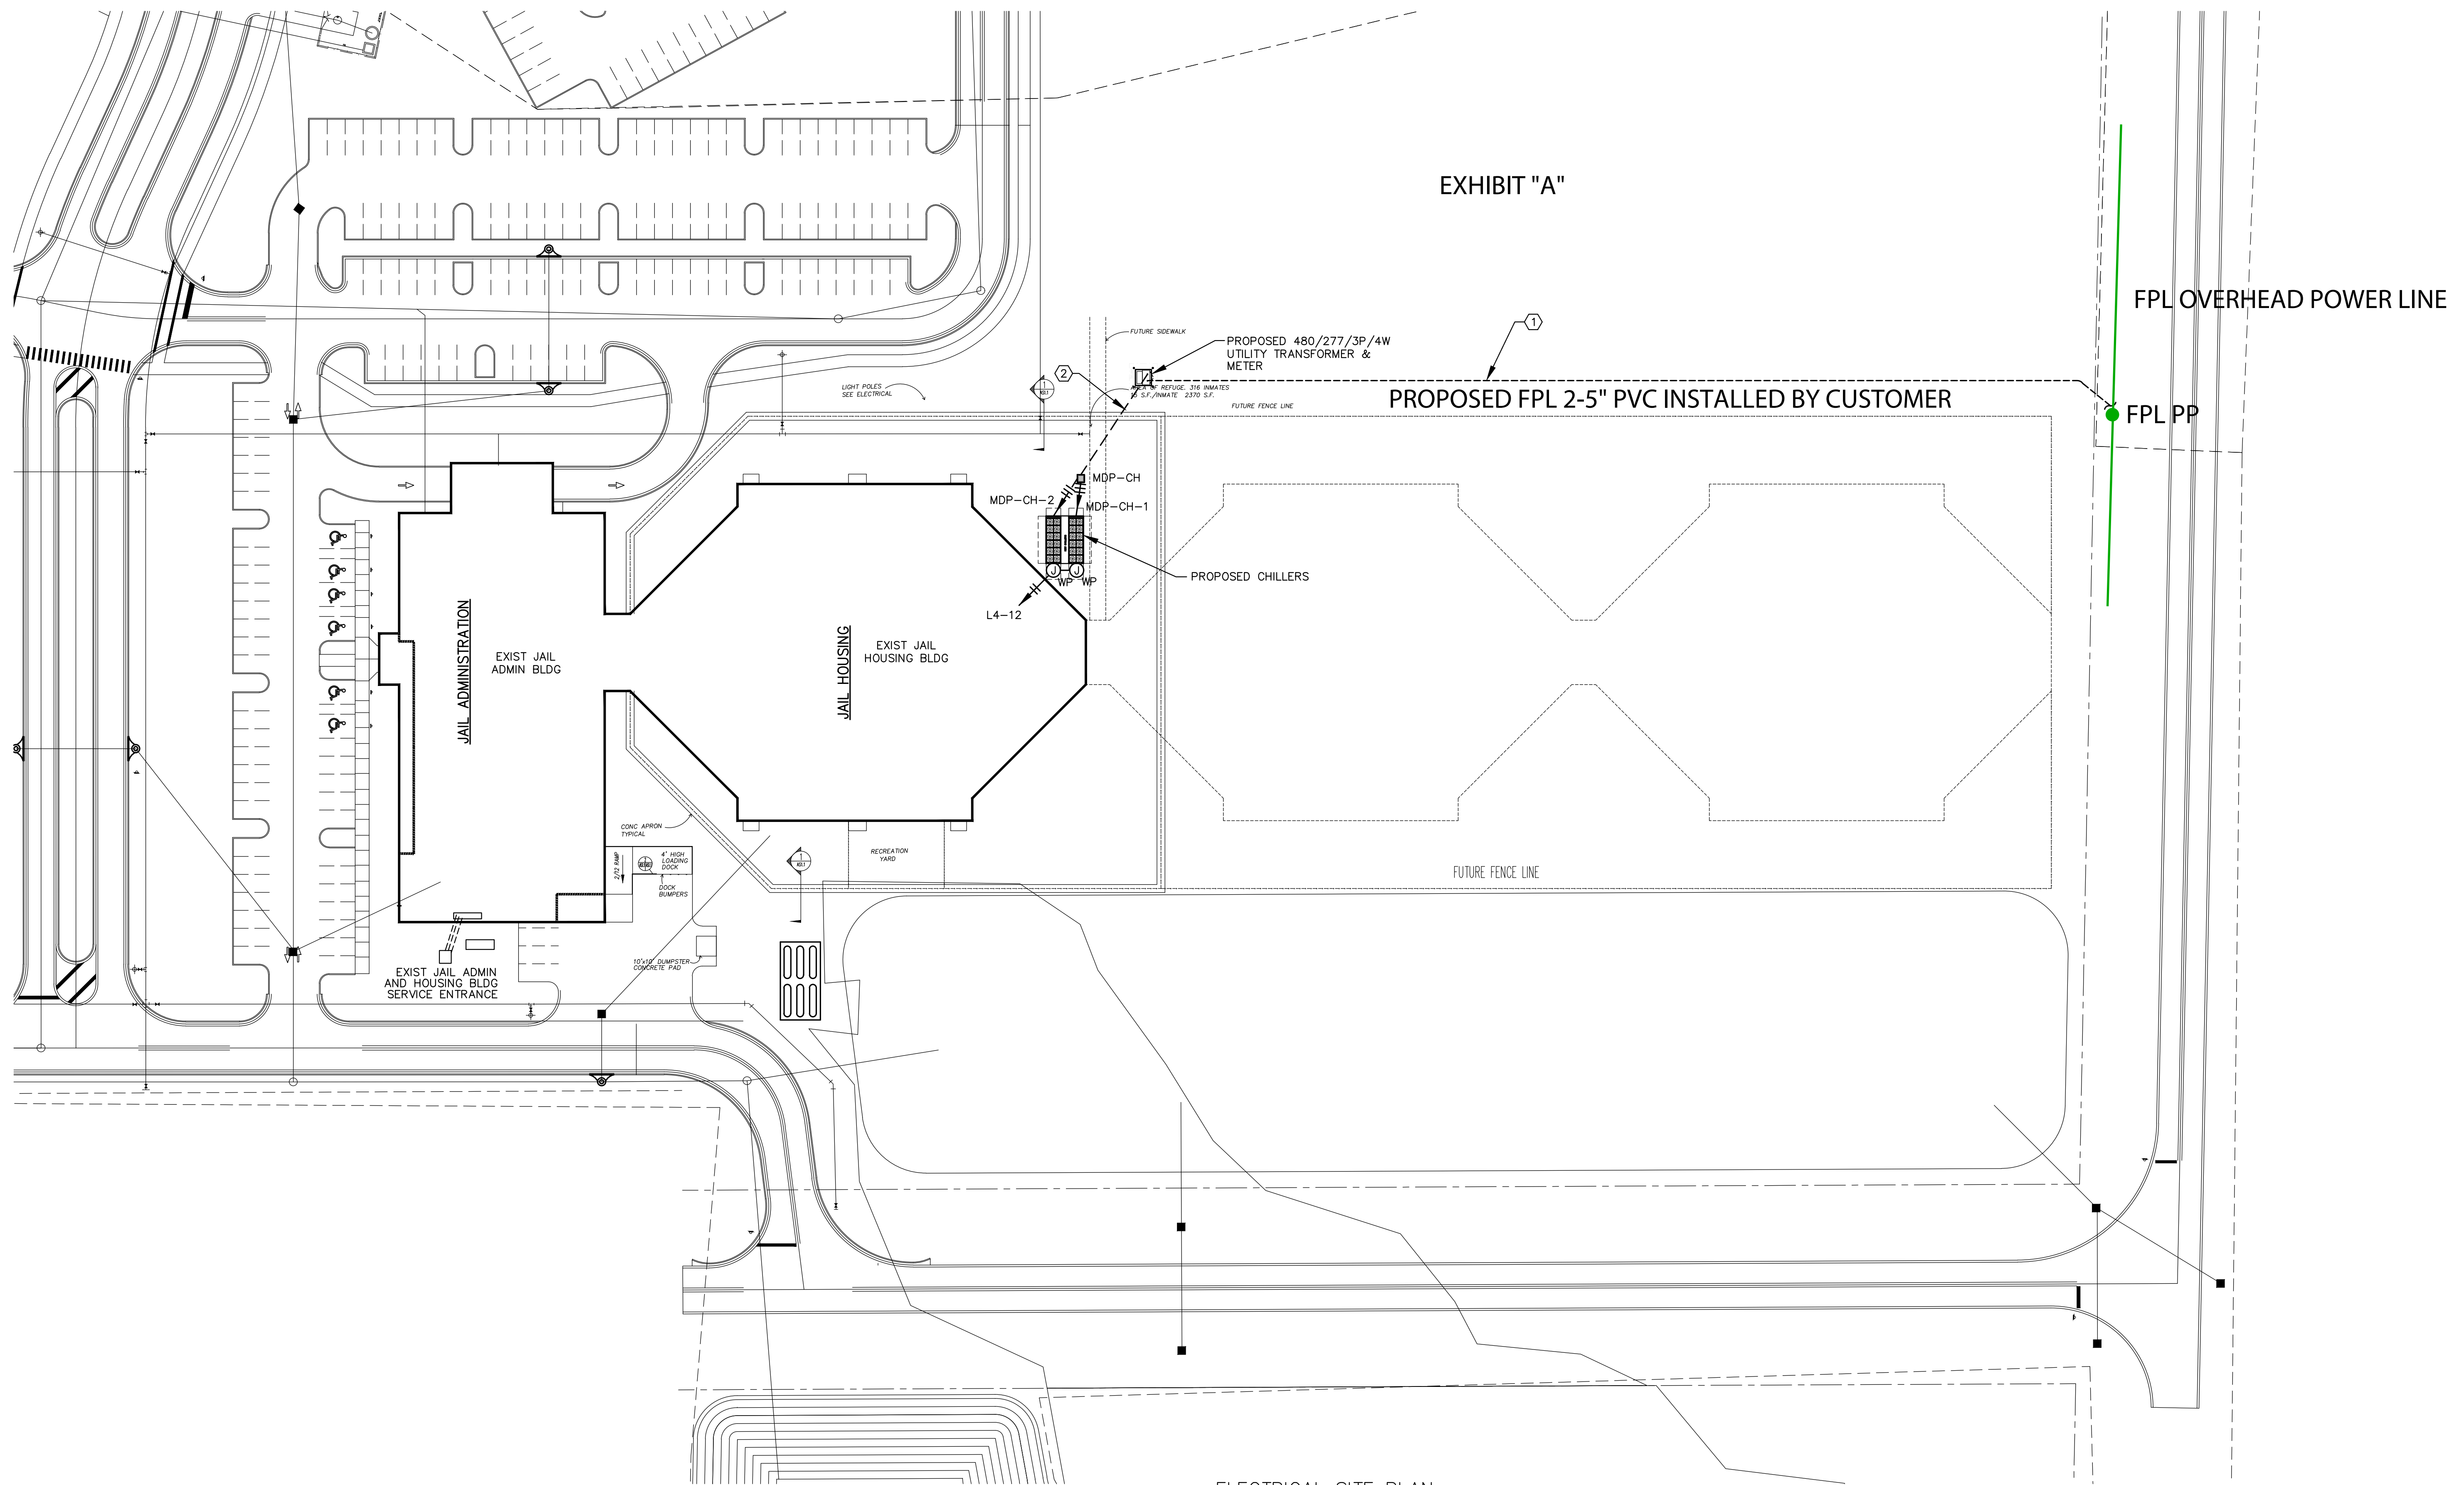


ELECTRICAL SITE PLAN
SCALE: 1" = 40'-0"

SITE PLAN NOTES:

1. PRIOR TO START OF ANY WORK OBTAIN WRITTEN APPROVAL FOR LOCATION OF TRANSFORMER, PRIMARY SERVICE CONDUIT & CONNECTION POINT PER ELECTRIC UTILITY CO. DIRECTION. CONTRACTOR SHALL BE RESPONSIBLE FOR OBTAINING AND COMPLYING WITH MOST CURRENT UTILITY RULES AND REGULATIONS. FP&L PROVIDED (2) 4" CONDUITS W/36" RADIUS ELLS AT TRANSFORMER & SERVICE CONNECTION POINT SHALL BE INSTALLED BY ELECTRICAL CONTRACTOR. CONDUIT SHALL HAVE PULLWIRE AND MAINTAIN 42" MINIMUM DEPTH. LOCATION OF TRANSFORMER, PRIMARY AND SECONDARY CONDUIT/FEEDER(S) ARE CONTINGENT UPON ELECTRICAL UTILITY CO. APPROVAL. PROVIDE TRANSFORMER PAD/ PROTECTIVE BOLLARDS AND GROUND RODS PER ELECTRICAL UTILITY CO. REQUIREMENTS. SEE 'POWER RISER' FOR ADDITIONAL REQUIREMENTS. COORDINATE WITH FP&L: ROBERT E. (BOB) HADDOCK (904) 225-3003, ROBERT.E.HADDOCK@FPL.COM
2. SERVICE ENTRANCE FROM ELECTRICAL UTILITY CO. XFMR, SEE 'POWER RISER' FOR ADDITIONAL REQUIREMENTS.

9/18/17
2801E01